


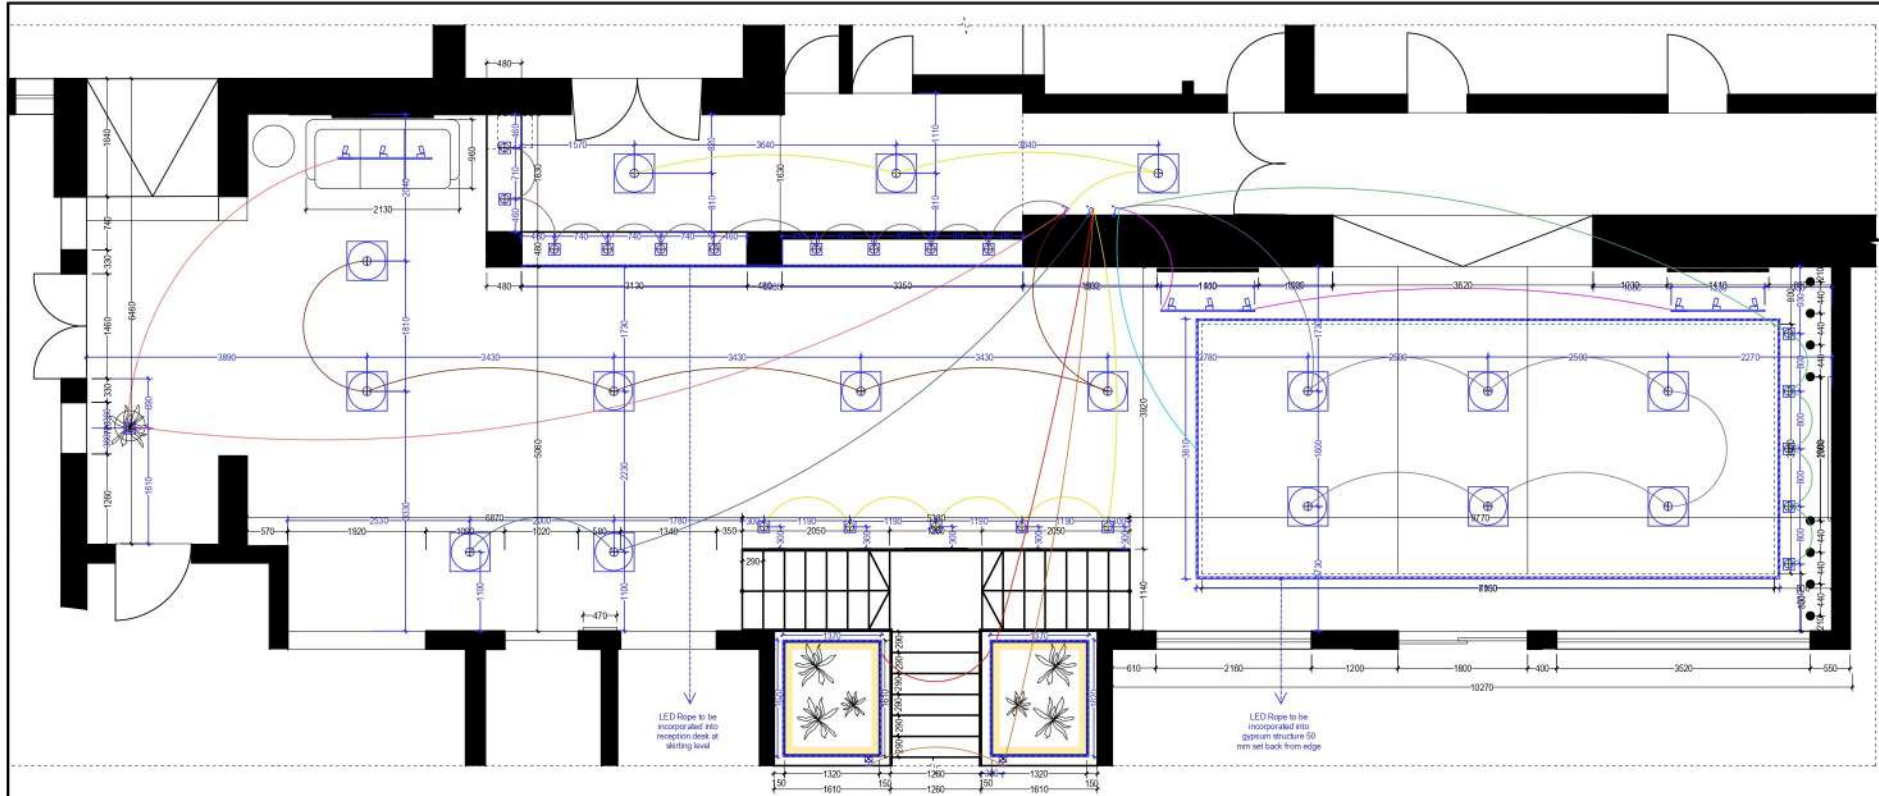

The contractor is to verify all dimensions and conditions on site. Furthermore all fixture modifications are to be approved in writing by a nominated PM, depending on the nature of the task. Any modifications to this design are to be first consulted and approved by the designer. This document is the intellectual property of the client. Reproduction without written consent is prohibited.

IM.18 | RECEPTION HALL LIGHTING LAYOUT

01 SCALE
1:100

INTERNAL LIGHT FIXTURES

-  SPOTLIGHT - 50 x 50 mm
-  SPOTLIGHT
-  CEILING SURFACE MOUNTED DIRECTIONAL SPOTLIGHT 100 x 100 mm
-  CEILING SURFACE MOUNTED DIRECTIONAL SPOTLIGHT 100 x 100 mm
-  PENDANT LIGHT FITTING
-  LOW LEVEL WALL LIGHT
-  LED STRIP LIGHTING
-  CEILING SURFACE MOUNTED CIRCLE LIGHT 450 x 450 mm

LIGHT SWITCHES

-  1 GANG / 1 WAY +1200 mm from FFL
-  2 GANG / 1 WAY +1200 mm from FFL
-  3 GANG / 1 WAY +1200 mm from FFL
-  4 GANG / 1 WAY +1200 mm from FFL
-  1 GANG / 2 WAY +1200 mm from FFL
-  2 GANG / 2 WAY +1200 mm from FFL
-  3 GANG / 2 WAY +1200 mm from FFL
-  4 GANG / 2 WAY +1200 mm from FFL
-  1 GANG / 1 WAY / DIMMER +1200 mm from FFL
-  2 GANG / 1 WAY / DIMMER +1200 mm from FFL
-  3 GANG / 1 WAY / DIMMER +1200 mm from FFL
-  4 GANG / 1 WAY / DIMMER +1200 mm from FFL

DRAWING

Lighting Layout

Name: IMO International Maritime Law Institute (IMLI)

Project ID: IDNMR-2024-05

Location: Msida

REVISION 000

DATE 24.04.2025

SCALE 1:100